
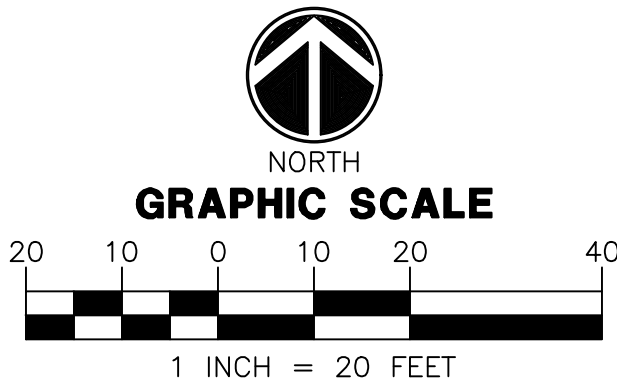


THESE DRAWINGS AND SPECIFICATIONS ARE THE SOLE PROPERTY OF WRIGHT ENGINEERING CORPORATION AND MAY NOT BE REPRODUCED OR MODIFIED FOR ANY USE WITHOUT THE EXPRESS WRITTEN PERMISSION OF WRIGHT ENGINEERING CORPORATION.
H:\2024\24124-Buffalo Wild Wings Site Lighting\24124-PH.dwg

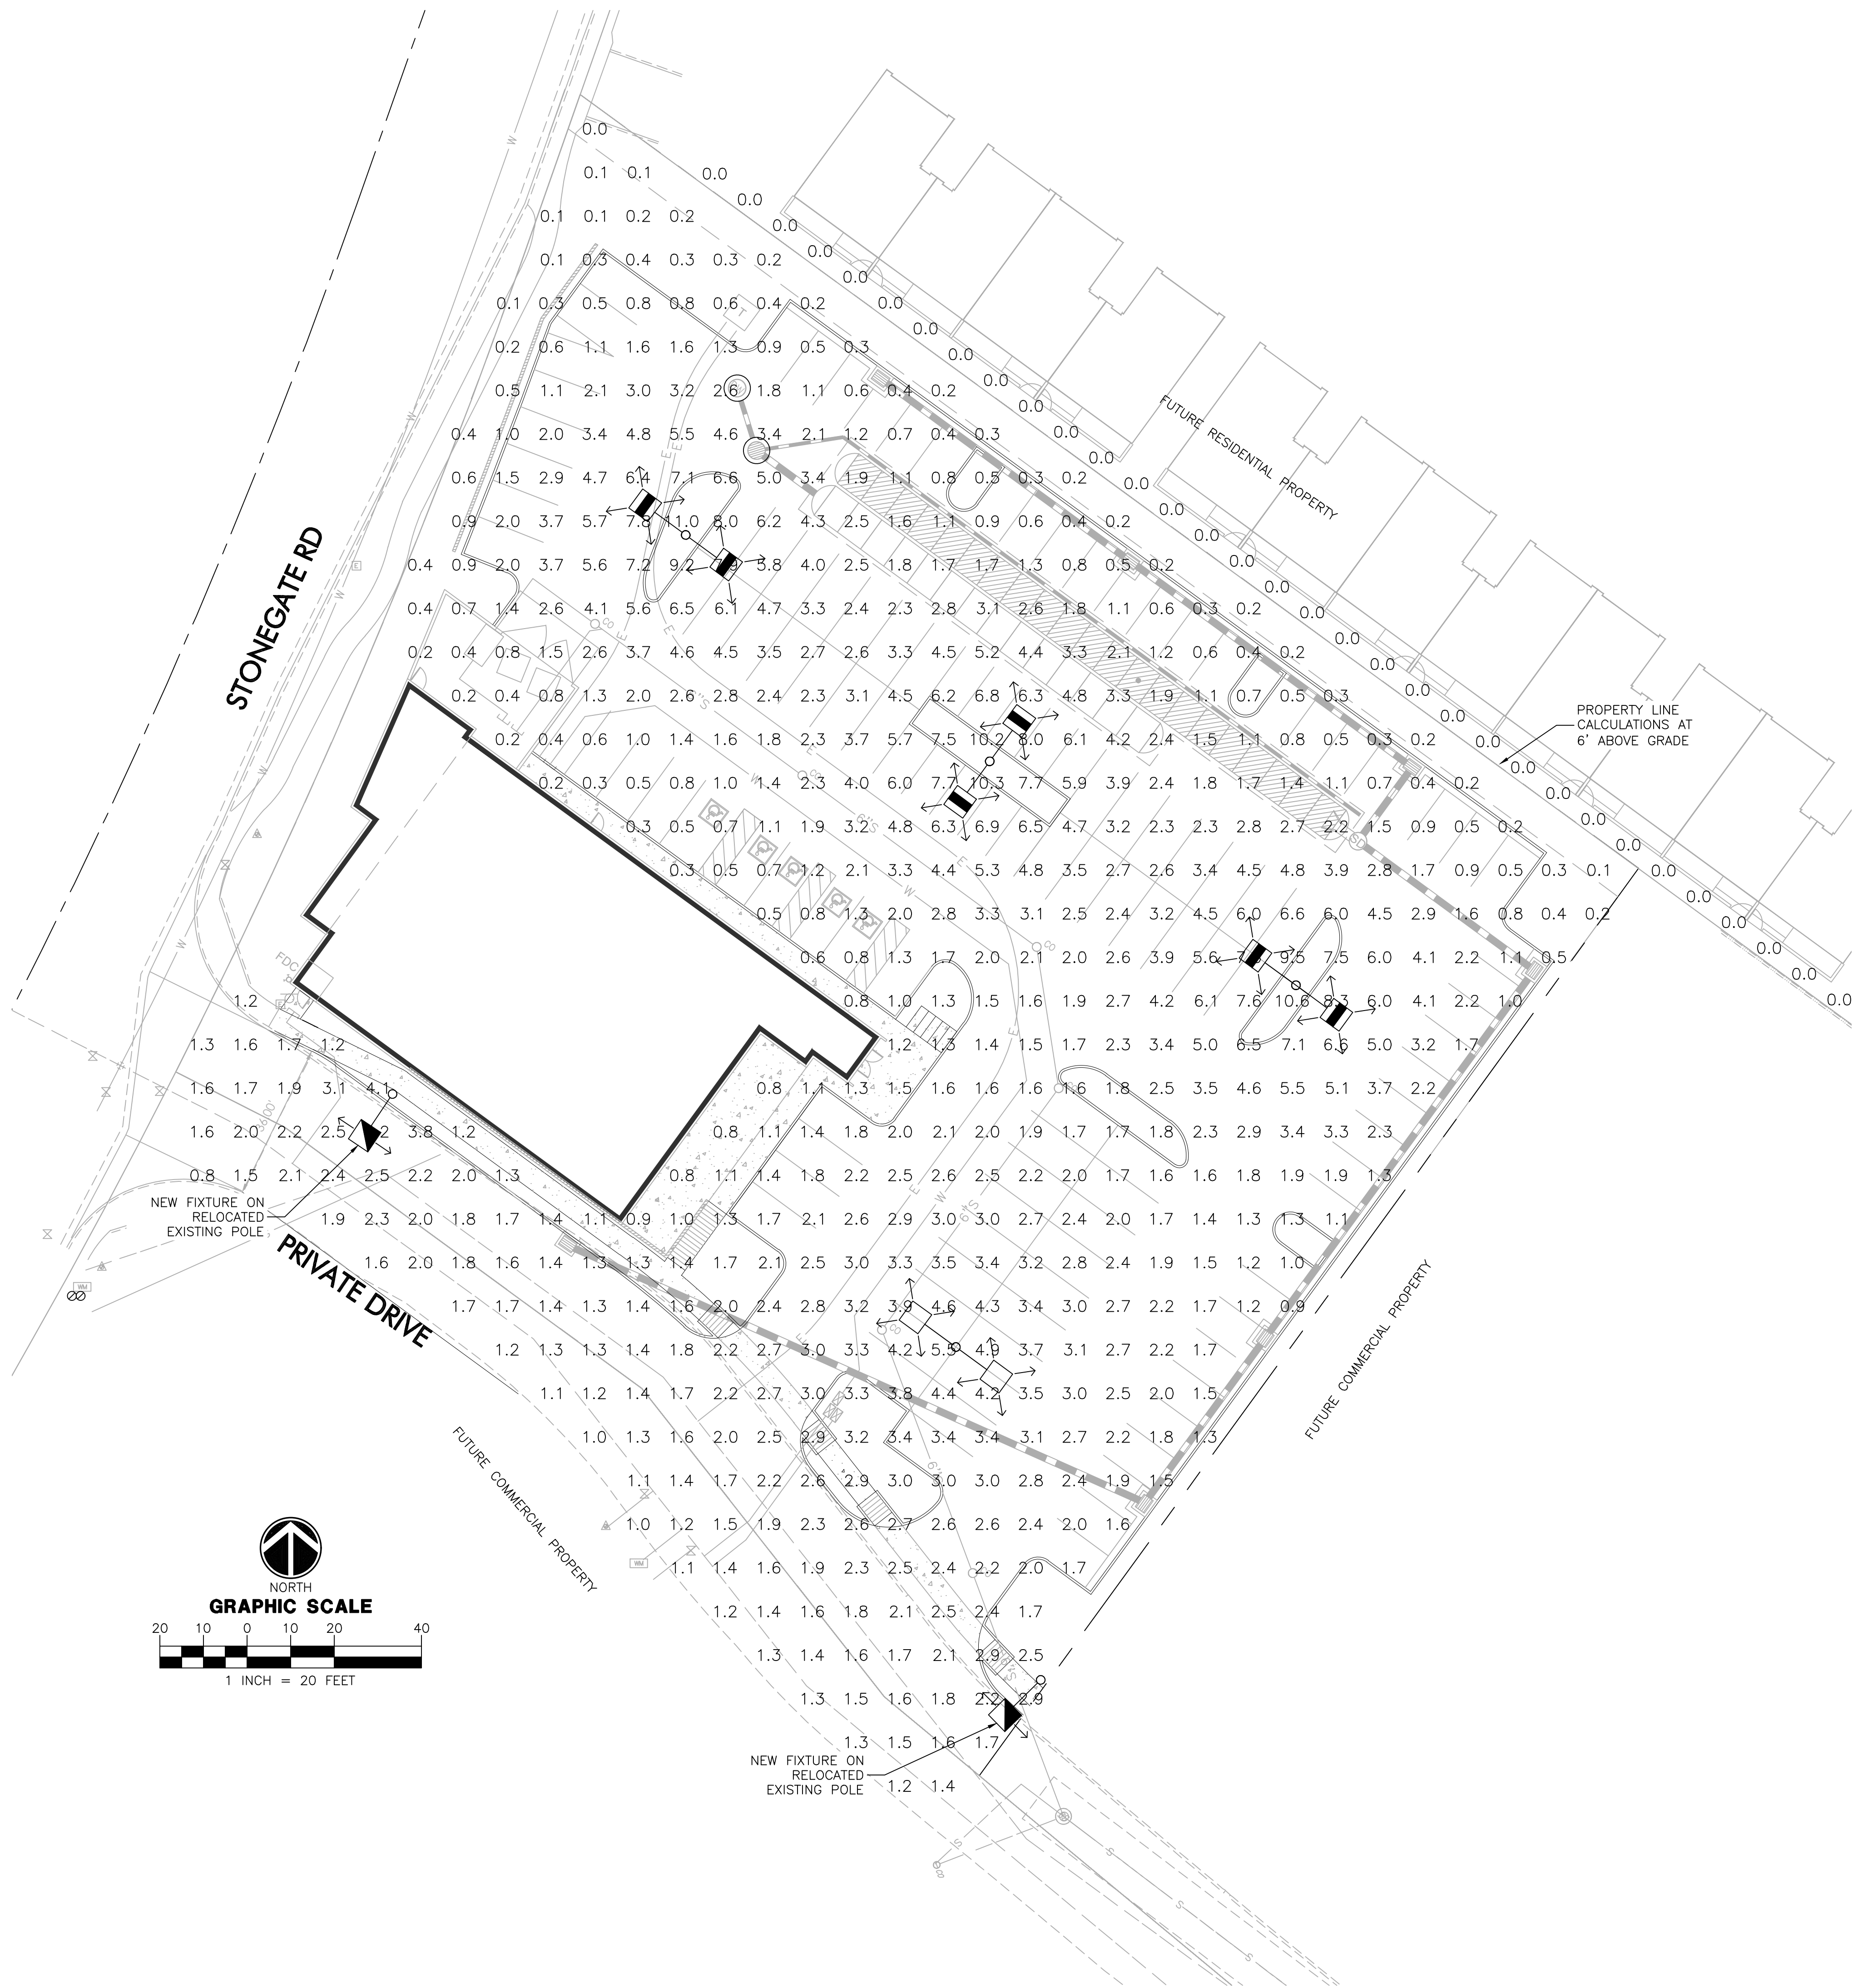

VICINITY MAP
NOT TO SCALE

PHOTOMETRIC LEGEND

- COOPER LIGHTING - McGRAW-EDISON
GALN-SA2D-730-U-SWQ
candela file 'GALN-SA2D-730-U-SWQ_14828 lumens.ies'
32 lamp(s) per luminaire, photometry is absolute
Light Loss Factor = 1.000, watts per luminaire = 125
mounting height= 14 ft
number locations= 6, number luminaires= 6
kw all locations= 0.8
- COOPER LIGHTING - McGRAW-EDISON
GALN-SA2C-730-U-SL2
candela file 'GALN-SA2C-730-U-SL2_12852 lumens.ies'
32 lamp(s) per luminaire, photometry is absolute
Light Loss Factor = 1.000, watts per luminaire = 108
mounting height= 25 ft
number locations= 2, number luminaires= 2
kw all locations= 0.2
- COOPER LIGHTING - McGRAW-EDISON
GALN-SA4B-730-U-SWQ
candela file 'GALN-SA4B-730-U-SWQ_21456 lumens.ies'
64 lamp(s) per luminaire, photometry is absolute
Light Loss Factor = 1.000, watts per luminaire = 164
mounting height= 25 ft
number locations= 2, number luminaires= 2
kw all locations= 0.3

CALCULATIONS

Site
570 points at z=0, sp 10ft by 10ft
HORIZONTAL FOOTCANDLES
Average 2.4
Maximum 11.0
Minimum 0.0
Avg:Min N/A
Max:Min N/A
Coef Var 0.78
UnifGrad N/A


Property Line
33 points at z=6, sp 8.06ft by 5.919ft
HORIZONTAL FOOTCANDLES
Average 0.0
Maximum 0.0
Minimum 0.0
Avg:Min N/A
Max:Min N/A
Coef Var 0.00
UnifGrad 5918.60

WRIGHT ENGINEERING
PROJECT NO:
24124
DESIGN BY: JDK
DRAWN BY: JDK
CHECKED BY: CRC

WRIGHT
engineering corporation
ELECTRICAL ENGINEERING AND DESIGN
165 EAST CHILTON DRIVE • CHANDLER, ARIZONA 85225
PHONE 480.497.5829 • FAX 480.497.5807
www.wrightengineering.us

PROJECT: TITLE:
**CITY OF MARICOPA, ARIZONA
BUFFALO WILD WINGS
AT MARICOPA POWER CENTER
PHOTOMETRIC SITE PLAN**

NO.	DATE	SUBMITTALS/REVISIONS (DESCRIPTIONS)

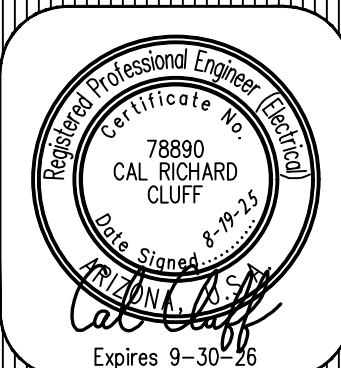

DRAWING NO:
PH1
OF 2



