



LUMINAIRE SCHEDULE									
CALLOUT	SYMBOL	LAMP	DESCRIPTION	MOUNTING	MODEL	VOLTS	NOTE 1	QUANTITY	INPUT W
OA	—	(1) LED(INCL)	4' EXTERIOR STRIP WITH POLYCARB LENS	SURFACE	BEGHELLI BS100LED4 HT MO WT50 120V-277V-FL	240V 2P 2W		258	60
OB	◻	(1)	LED POLE FIXTURE	POLE	Lithonia Lighting, RSX2 LED P4 40K R4	MULTIPLE		1	189.54
OE2	•	(1)	LED WALL PACK	WALL	Lithonia Lighting, WDGE3 LED P3 70CRI RFT 40K MVOLT	MULTIPLEFULL CUT OFF		3	71.6952

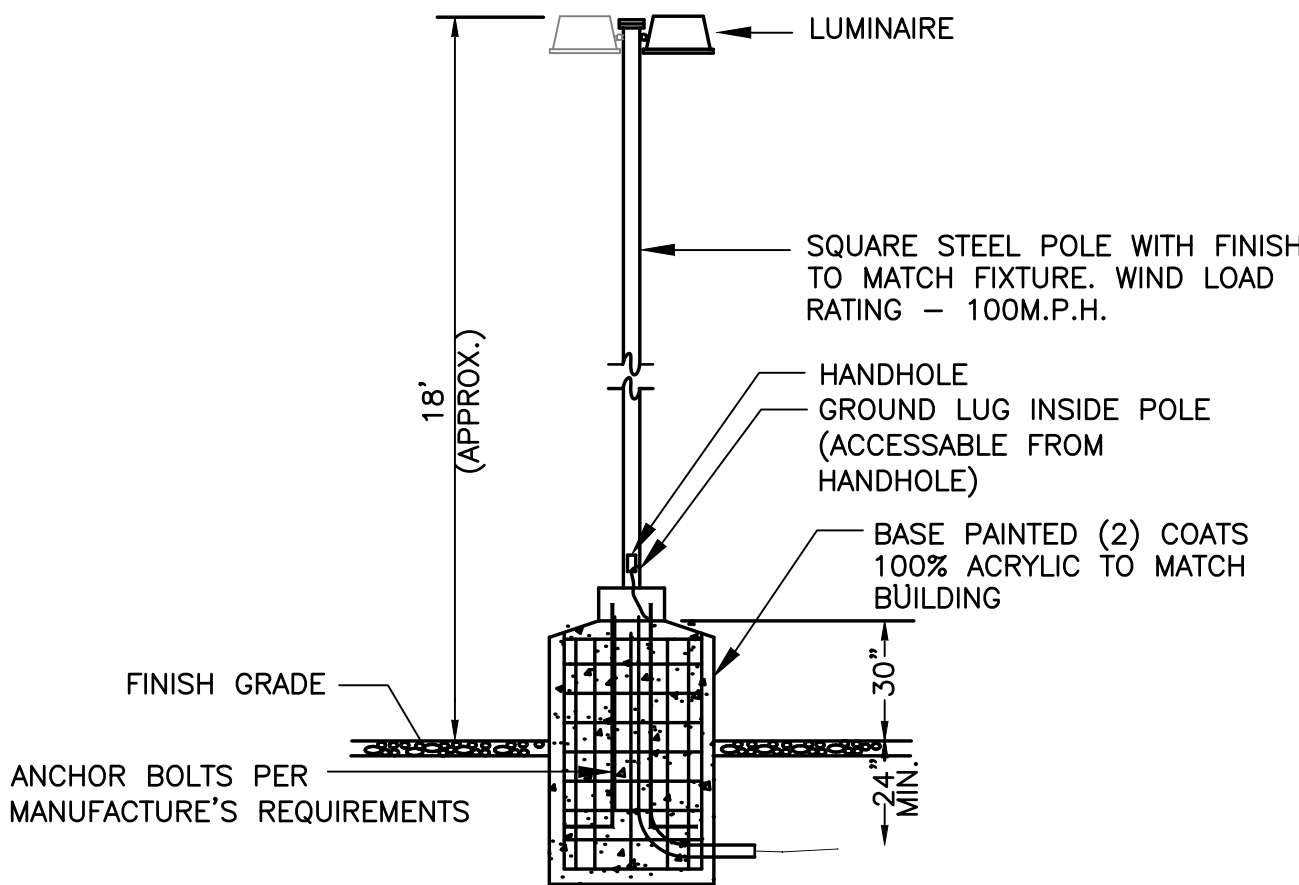

- NOTES:
1. LIGHT POLE SHALL WITHSTAND 100MPH WIND FORCE WITH A 1.3 GUST FACTOR.
 2. THIS POLE BASE DETAIL IS FOR ELECTRICAL SYSTEMS ONLY. THE STRUCTURAL DESIGN SHALL BE PROVIDED BY A STRUCTURAL ENGINEER.

LIGHT POLE DETAIL

N.T.S.

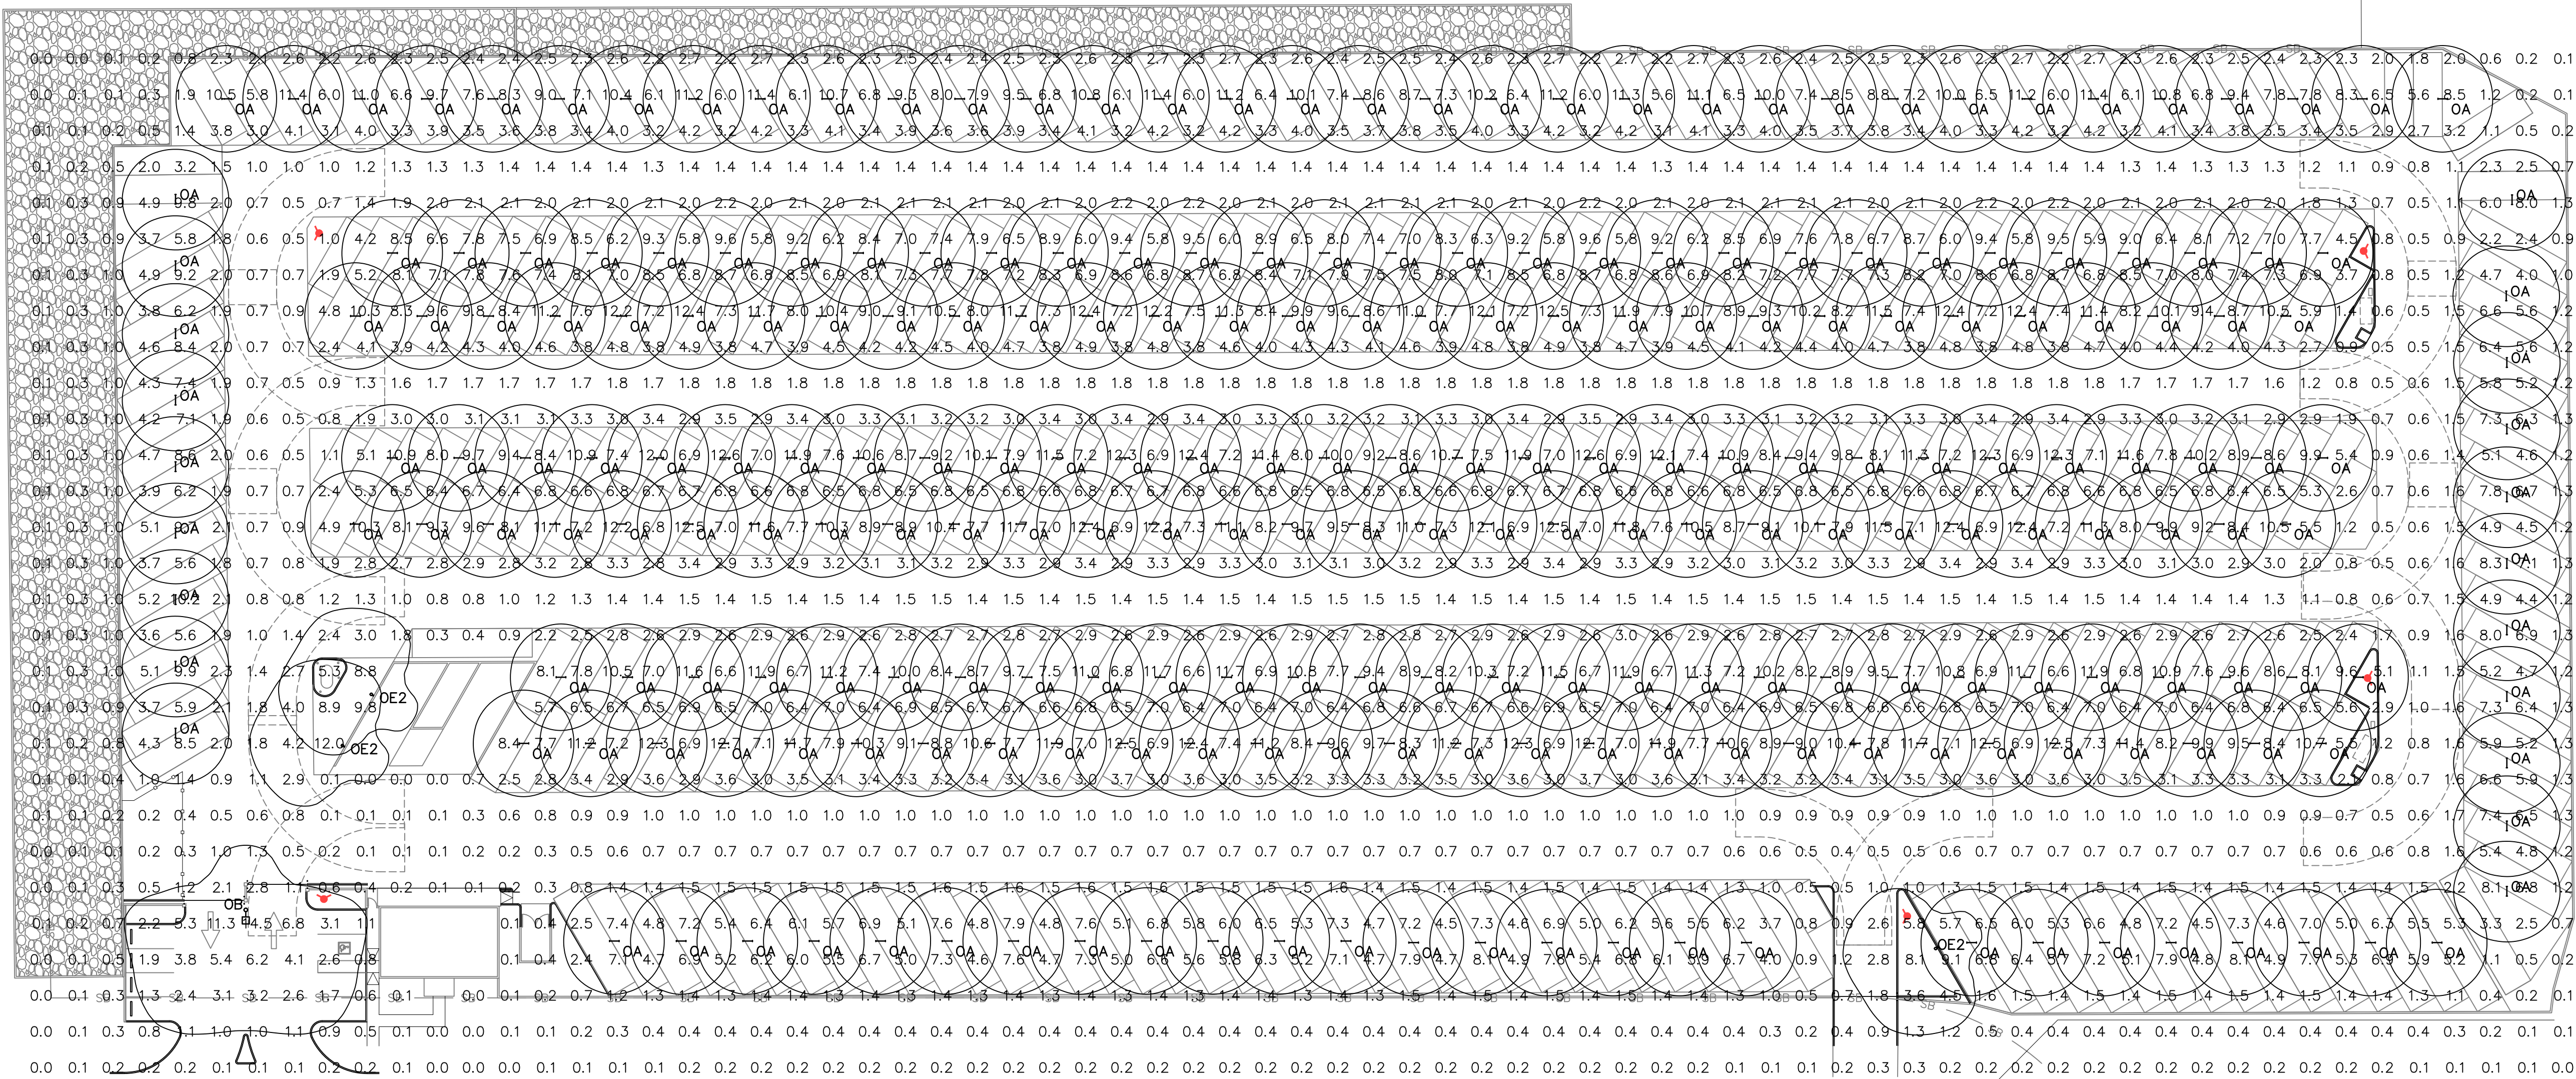

CLIENT/PROJECT:

CareFree RV Storage Facility
NEC Loma Rd. & Estrella Pkwy.
Maricopa, Arizona

SHEET TITLE:
SITE PHOTOMETRIC PLAN

DATE:

PROJ. NO.:

SCALE:

CHK'D BY:

DRAWN BY:

SHEET

